


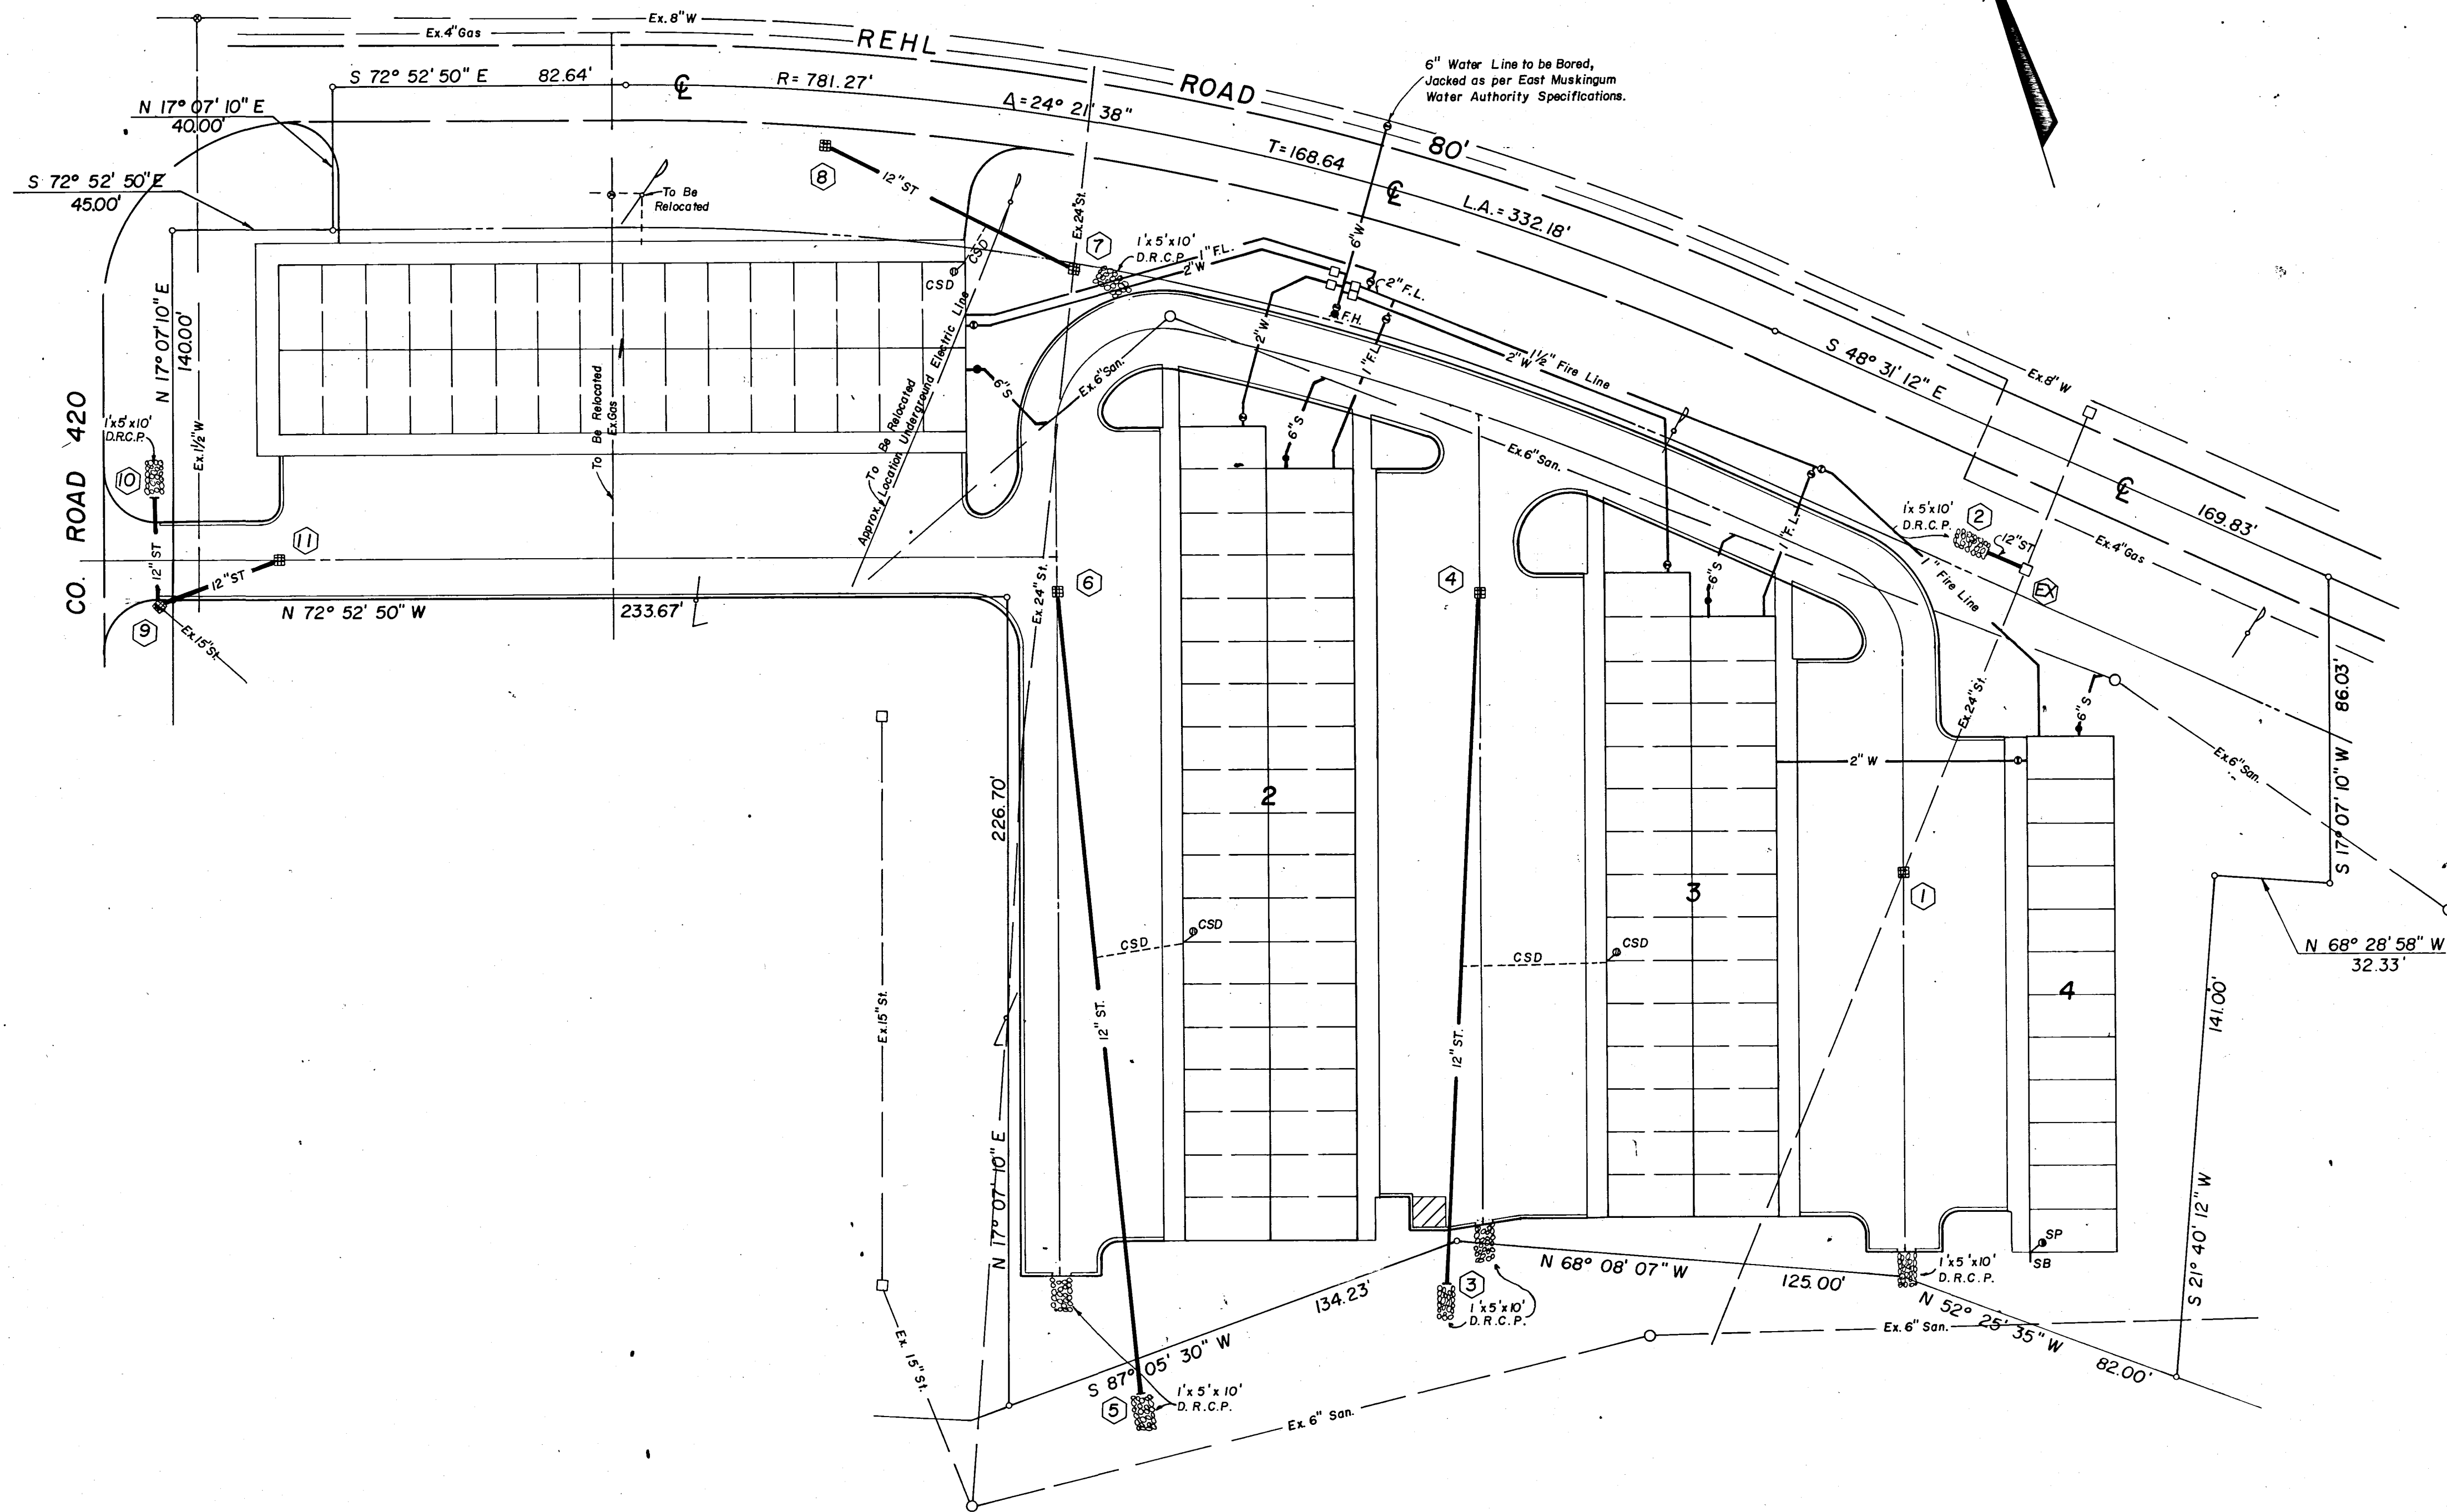

LEGEND	
EXISTING	PROPOSED
—San.— Sanitary Sewer	—SAN— Sanitary Sewer
○ Manhole	—S— Sanitary Service
—St— Storm Sewer	• Sanitary Cleanout
□ Storm Inlet	② Sanitary Manhole Number
—W— Water Line	● Manhole
• Valve & Box	—ST— Storm Sewer
• Fire Hydrant	—St— Storm Inlet
• Light, Power, or Telephone Pole	③ Storm Manhole, Inlet, or Outlet Number
—G— Gas Line	—W— Water Line
	• Valve & Box
	• Fire Hydrant
	• Down Spout Drain
	—S.B.— Splash Block
	—C.S.D.— Crawl Space Drain
	• Crawl Space Drain Inlet
	• Storm Endwall or Headwall
	• Yard Light
	• SP Sump Pump

BLACKBURN, GRASHEL, KOSANCHICK & ASSOCIATES, INC.
 CONSULTING ENGINEERS & SURVEYORS
 2101 SOUTH HAMILTON ROAD
 COLUMBUS, OHIO 43227
 PHONE: 614/861-7211

FALLS TOWNSHIP, MUSKINGUM CO., OHIO
COMPOSITE UTILITY PLAN

SCALE: 1"=30'
 DATE: FEB., 1981
 DRAWN: SWQ
 CHECKED: RAH
 FILE NO. SHEET
 884-81 **6**