

MUSKINGUM COUNTY

GAMBRO HEALTHCARE

LIFT STATION AND FORCE MAIN

OCTOBER 2003

File for
future ref.

ODOT STANDARD DRAWINGS

MH-1.1 MH-1.2
DM-4.3 DM-4.4
MT-105.10 MT-105.11
MT-97.10

ESTIMATED QUANTITIES			
ITEM NO.	DESCRIPTION	UNIT	QUANTITY
207	SPECIAL - CONSTRUCTION EROSION CONTROL	LUMP SUM	
253	PAVEMENT REPAIR, AS PER PLAN	S.Y.	11
603	SPECIAL - 3" SANITARY FORCE MAIN, HDPE, DIRECTIONAL BORED, AS PER PLAN	L.F.	5435
603	SPECIAL - 3" SANITARY FORCE MAIN, HDPE, IN CASING PIPE, AS PER PLAN	L.F.	64
603	6" CONDUIT, TYPE B, POLYVINYL CHLORIDE SOLID WALL PIPE SDR 35, PUSH-ON JOINTS & FITTINGS	L.F.	40
603	8" CONDUIT, TYPE B, POLYVINYL CHLORIDE SOLID WALL PIPE SDR 35, PUSH-ON JOINTS & FITTINGS	L.F.	35
604	MANHOLE TYPE 3	EACH	1
604	SPECIAL - 3" CLEANOUT, AS PER PLAN	EACH	5
614	MAINTAINING TRAFFIC	LUMP SUM	
623	CONSTRUCTION LAYOUT STAKES	LUMP SUM	
624	MOBILIZATION	LUMP SUM	
638	SPECIAL-12" CASING PIPE, BORED OR JACKED	L.F.	64
638	SPECIAL-2" COMBINATION AIR RELEASE VALVE, AS PER PLAN	EACH	2
680	SPECIAL - GRINDER PUMP LIFT STATION, AS PER PLAN	LUMP SUM	

INDEX OF SHEETS

DESCRIPTION	SHEET NO.
TITLE SHEET	1
GENERAL NOTES	2-3
FORCE MAIN PLAN AND PROFILE	4-7
LIFT STATION DETAILS	8
MISCELLANEOUS DETAILS	9-10
EROSION & SEDIMENT CONTROL DETAILS	11

UNDERGROUND UTILITIES

2 WORKING DAYS



BEFORE YOU DIG

CALL 800-362-2764 (TOLL FREE)

OHIO UTILITIES PROTECTION SERVICE

NON-MEMBERS

MUST BE CALLED DIRECTLY

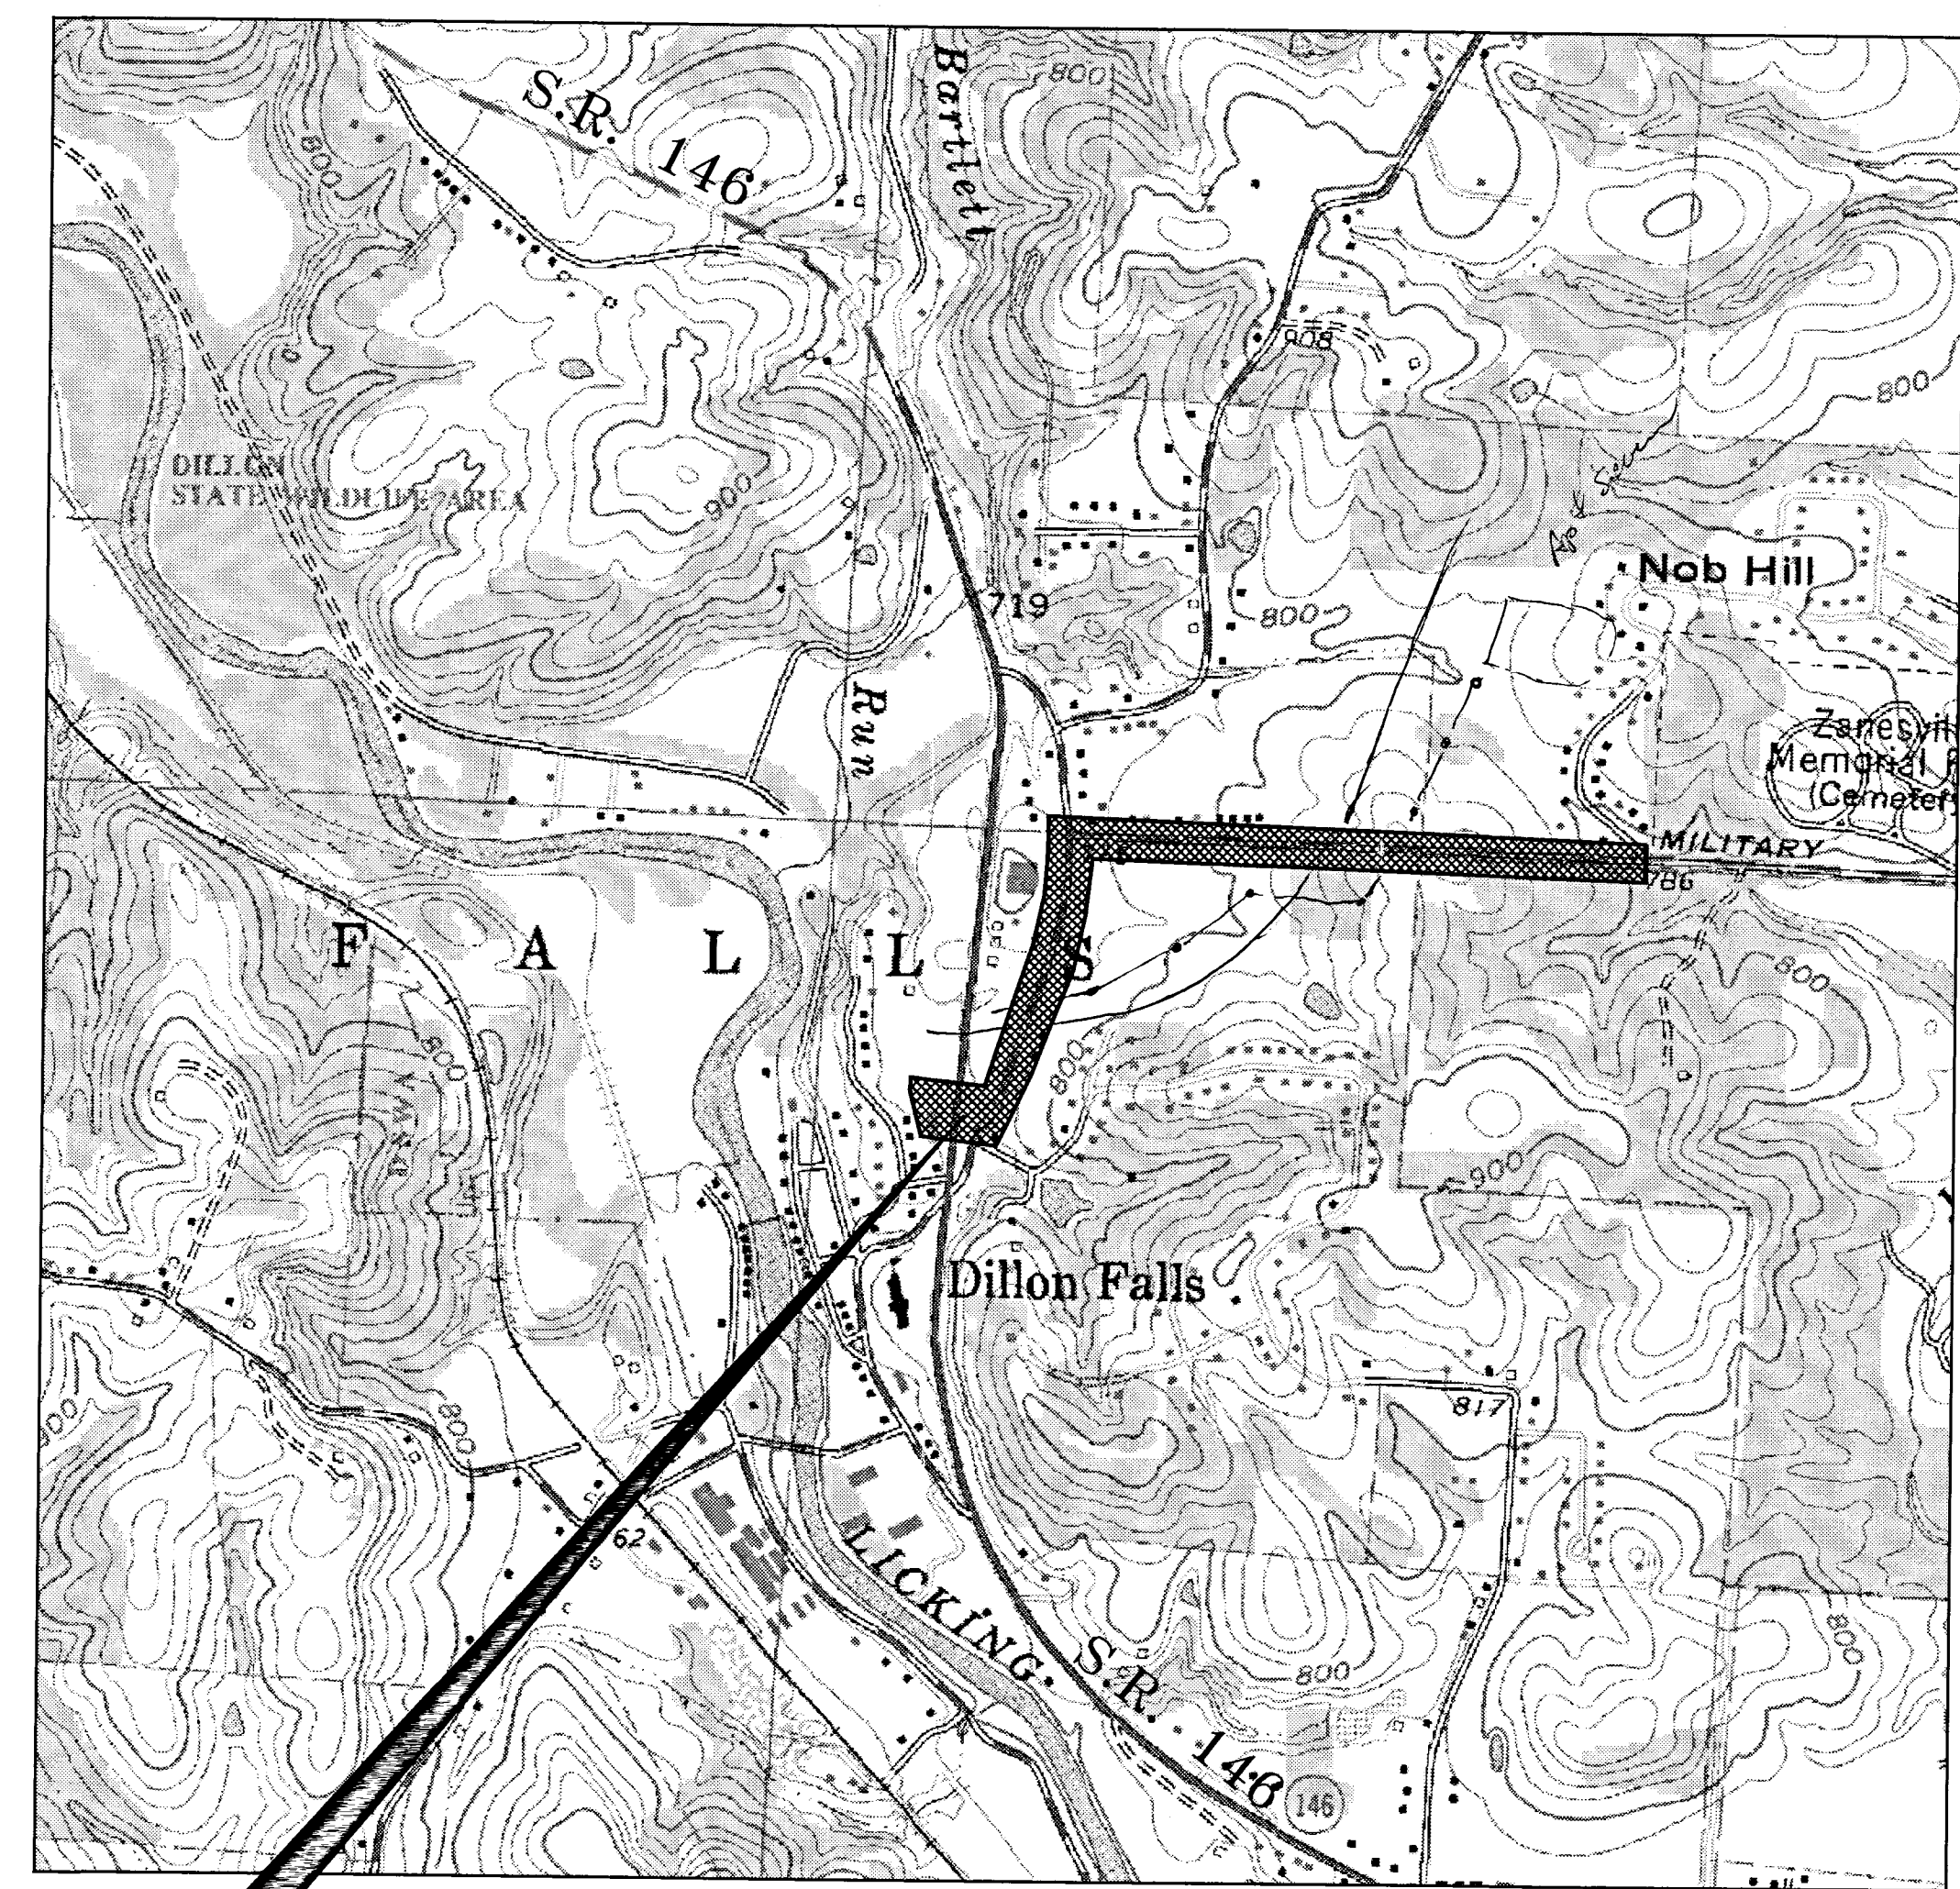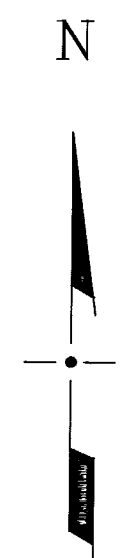


PROJECT LOCATION

PROJECT LOCATION/VICINITY MAP
SCALE: 1" = 1000'



PROJECT LOCATION

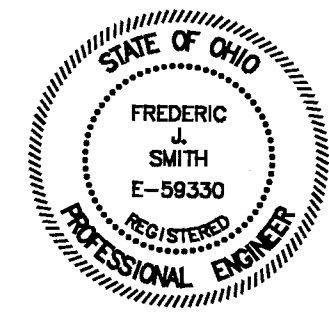

FREDERIC J. SMITH, P.E. E-59330 REG. NO. DATE

PLANS PREPARED BY :

URS Corporation

277 WEST NATIONWIDE BLVD. COLUMBUS, OHIO 43215 614/464-4500

ABDEL-LATIF A11302 3/14/03 11/05/03 06:19 LUS 1 PLS:0